


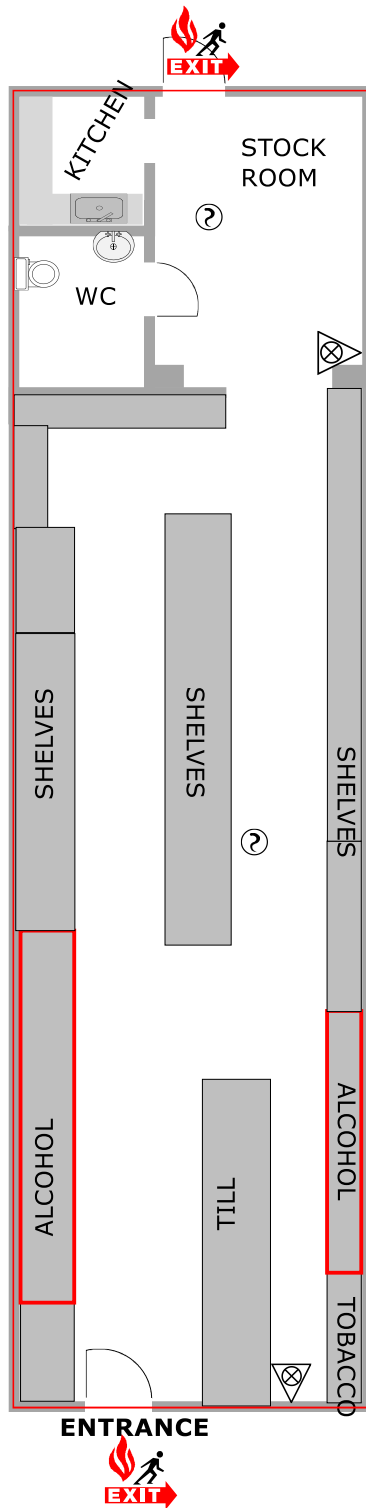


FLOOR PLAN FOR

BLACK LION FOOD EXPRESS

42 Tottenham Ln,
London N8 8PT

Metric Scale

 1:100



 Fire extinguisher

 Smoke detector

 Ambit of premises

Drawn by

KAPLAN CONSULTING LTD

kaplanconsultinguk@gmail.com

+447742013801

Date

06/01/2025